


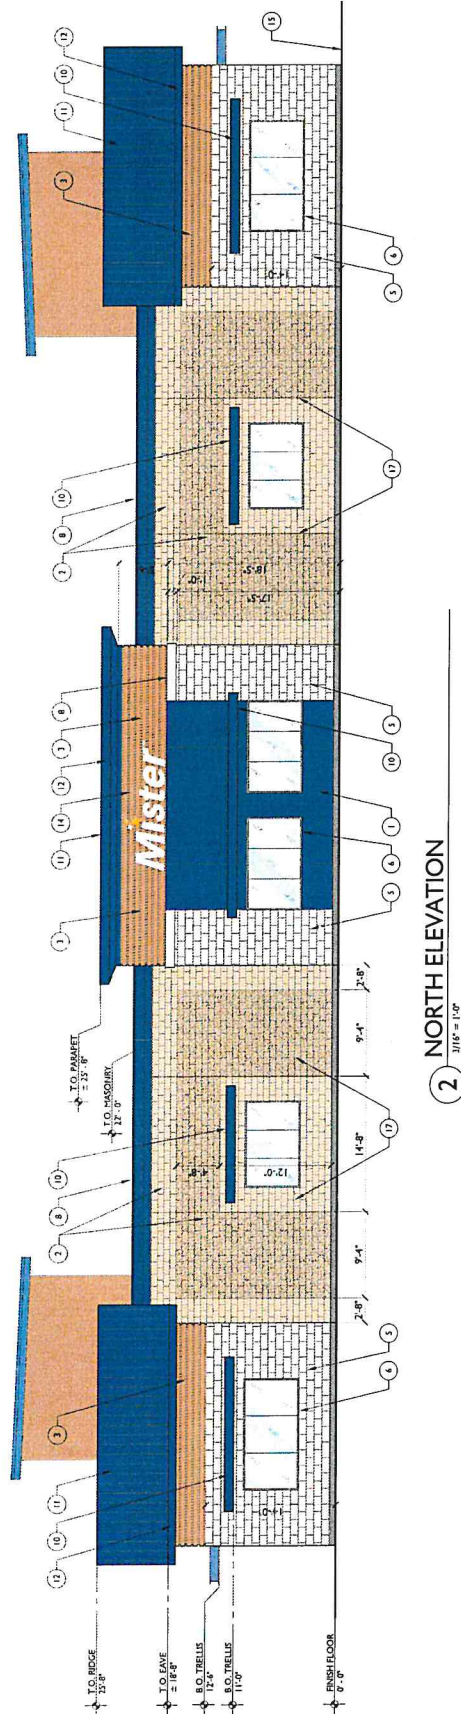


2 NORTH ELEVATION
3/16" = 1'-0"

- GENERAL ELEVATION NOTES:**
1. ALL SIGNAGE SHOWN FOR INFORMATIONAL PURPOSES ONLY. ALL ADVERTISING SIGNAGE SUBJECT TO SEPARATE SIGN PERMIT SUBMITTAL AND APPROVAL.
 2. EXTERIOR LIGHTING NOT SHOWN. SEE ELECTRICAL PLANS FOR LOCATION AND REQUIREMENTS.
 3. APPLY CLEAR WATERPROOF SEALER TO ALL EXPOSED STONE VENEER AND CHIL.

BUILDING ELEVATIONS

1 WEST ELEVATION
3/16" = 1'-0"

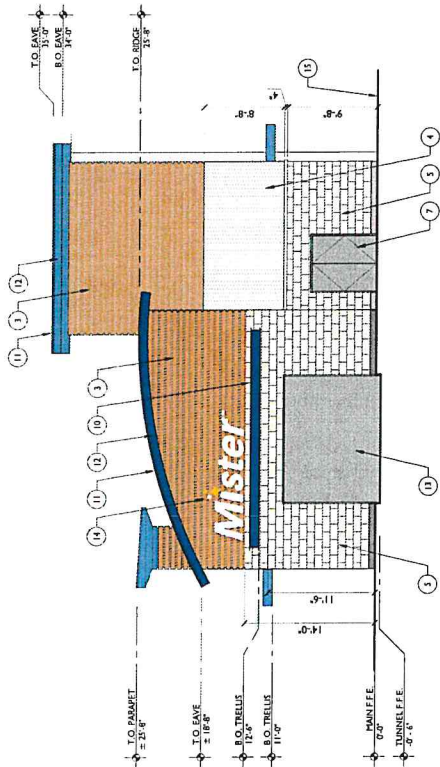

ELEVATION KEYNOTES:

1. EIFS EXTERIOR WALL PER WALL TYPE - PAINTED STUCCO FINISH W/ COORDINATE COLOR. SEE FINISH SCHEDULE.
2. EXPOSED CHU WALL PER WALL TYPE. TEXTURED ACCENT AS SHOWN. SEE FINISH SCHEDULE.
3. PAINTED STUCCO FINISH W/ COORDINATE COLOR. SEE FINISH SCHEDULE.
4. PRE-FINISHED COATED METAL WALL PANEL PER WALL TYPE. COORDINATE COLOR AS SHOWN.
5. MANUFACTURED STONE VENEER EXTERIOR WALL PER WALL TYPE. COORDINATE COLOR AS SHOWN. SEE FINISH SCHEDULE.
6. MANUFACTURED STONE VENEER EXTERIOR WALL PER WALL TYPE. COORDINATE COLOR AS SHOWN. SEE FINISH SCHEDULE.
7. INSULATED HOLLOW METAL DOOR AND FRAME ASSEMBLY. PAINT COORDINATE COLOR. SEE FINISH SCHEDULE. DETAIL SHEET FOR MORE INFORMATION.
8. EIFS ACCENT / CORNICE BAND - PAINTED STUCCO FINISH. COORDINATE COLOR. SEE FINISH SCHEDULE.
9. COORDINATE COLOR. SEE FINISH SCHEDULE.
10. POWDER COATED METAL TRELLIS.
11. PRE-FINISHED STANDING SEAM METAL ROOF PER ROOF PLAN / DETAIL.
12. PRE-FINISHED CORRUGATED METAL FASCIA AND SOFFIT.
13. UP DOOR PER DOOR SCHEDULE.
14. BUILDING SIGNAGE LOCATION. COORDINATE ALL REQUIREMENTS. SEE FINISH SCHEDULE.
15. PRE-FINISHED CORRUGATED METAL CHANNEL PER STUCCO FINISH. COORDINATE COLOR AS SHOWN. SEE FINISH SCHEDULE.
16. PAINTED CONTROL DIRT AS SHOWN W/ SEALANT TO HATCH. COORDINATE COLOR AS SHOWN. SEE FINISH SCHEDULE.
17. EXTERIOR LIGHTING NOT SHOWN. SEE ELECTRICAL PLANS FOR LOCATION AND REQUIREMENTS.
18. EXTERIOR LIGHTING NOT SHOWN. SEE ELECTRICAL PLANS FOR LOCATION AND REQUIREMENTS.
19. PAINTED TRELLIS PER OFFICE WINDOW. THIS LOCATION ONLY.



Expires 06/30/20
Revised

BUILDING ELEVATIONS


Mister

ELEVATION KEYNOTES:


1. EIFS EXTERIOR WALL PER WALL TYPES - PAINTED STUCCO FINISH W/ EXPOSED CHU WALL PER WALL TYPES - TEXTURED ACCENT AS SHOWN. SEE FINISH SCHEDULE.
2. EXPOSED CHU WALL PER WALL TYPES - TEXTURED ACCENT AS SHOWN. SEE FINISH SCHEDULE.
3. TYPES ORIENTATION AS SHOWN.
4. PRE FINISHED CORRUGATED METAL WALL PANEL PER WALL TYPES.
5. MANUFACTURED STONE VENEER EXTERIOR WALL PER WALL TYPES.
6. ALUMINUM STOREFRONT WINDOW / DOOR SYSTEM - REFERENCE MANUFACTURER'S INSTALLATION INSTRUCTIONS FOR CORRECT INSULATED HOLLOW METAL DOOR AND FRAME ASSEMBLY. PAINT COLOR PER ARCHITECT. REFERENCE DOOR SCHEDULE. DETAIL 10.00.
7. EIFS ACCENT / CORNER BAND - PAINTED STUCCO FINISH.
8. POWER COATED METAL AWNING.
9. POWER COATED METAL AWNING.
10. PRE FINISHED CORRUGATED METAL ROOF PER ROOF PLAN / TYPE.
11. PRE FINISHED CORRUGATED METAL ROOF PER ROOF PLAN / TYPE.
12. BUILDING SIGNAGE LOCATION. COORDINATE ALL REQUIREMENTS.
13. FINISH GRADE AS OCCURS.
14. BUILDING SIGNAGE LOCATION. COORDINATE ALL REQUIREMENTS.
15. FINISH GRADE AS OCCURS.
16. BUILDING SIGNAGE LOCATION. COORDINATE ALL REQUIREMENTS.
17. REF. STRUCTURAL PLANS FOR REQUIREMENTS.
18. MECHANICAL PLUMBING / ELECTRICAL PLUMBING AS SHOWN.
19. PROTECTED / TINTED FILM AT OFFICE WINDOW. THIS LOCATION ONLY.

GENERAL ELEVATION NOTES:

1. ALL SIGNAGE SHOWN FOR INFORMATIONAL PURPOSES ONLY. ALL ADVERTISING SIGNAGE SUBJECT TO SEPARATE SIGN PERMIT SUBMITTAL AND APPROVAL.
2. EXTERIOR LIGHTING NOT SHOWN. SEE ELECTRICAL PLANS FOR LOCATIONS AND REQUIREMENTS.
3. APPLY CLEAR WATERPROOF SEALER TO ALL EXPOSED STONE VENEER AND CHU.

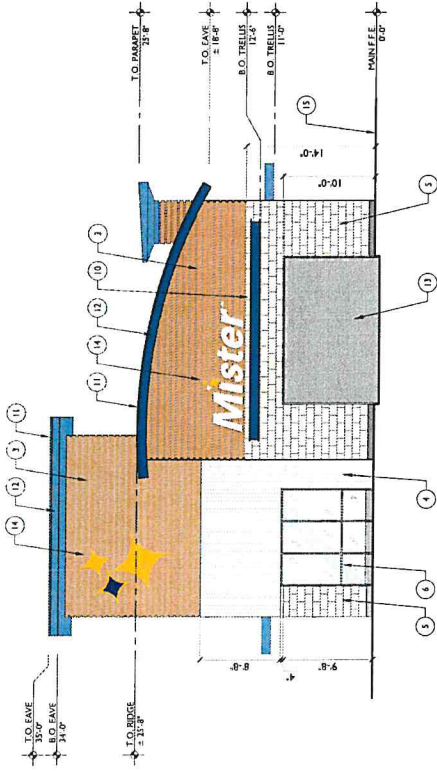

3 EAST ELEVATION
3/16\"/>

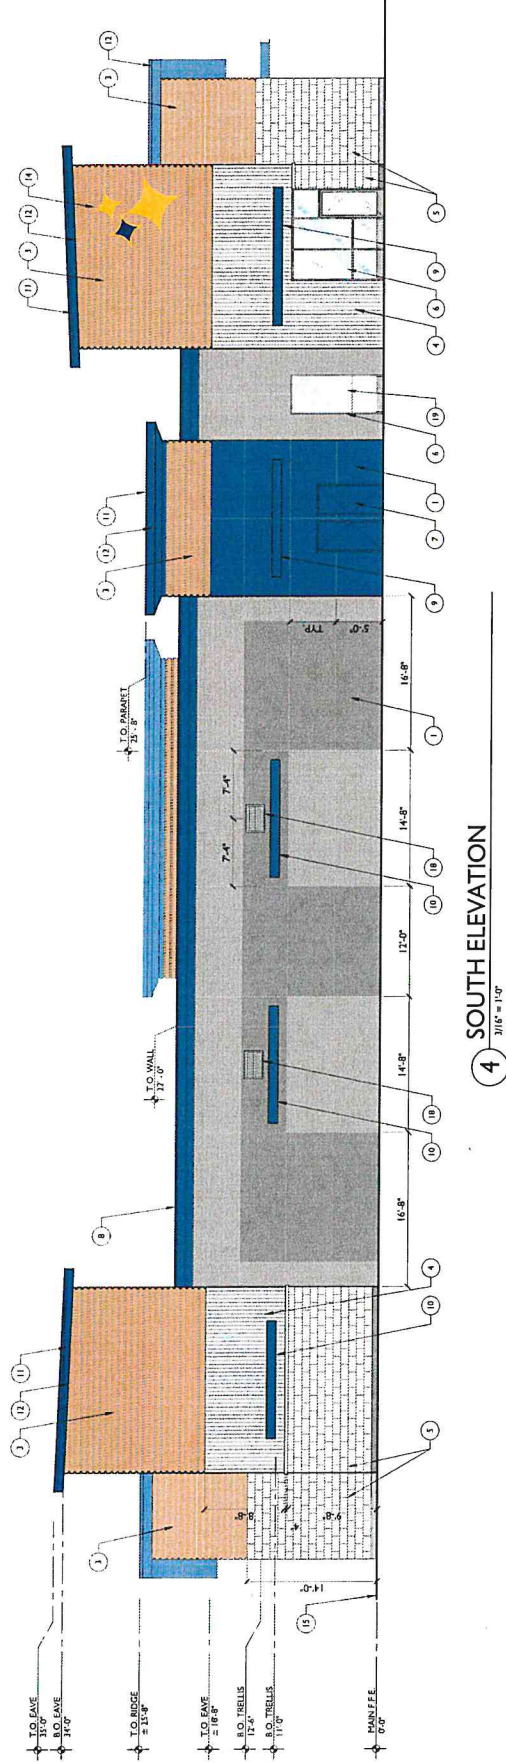

4 SOUTH ELEVATION
3/16\"/>

Mister Car Wash
1400 Greer Rd.
Turlock, CA 95380

a.23 studios
3400 North California Ave.
Turlock, CA 95380
Phone: 209.338.0000
www.a23studios.com

Project: 19951
Date: 06.14.19
Scale: Noted
Sheet: 8

A5.1